

**PACKAGE AIR CONDITIONING UNIT SCHEDULE**

MARK	TOTAL COOLING BTU/HR.	TOTAL SENSIBLE BTU/HR.	TOTAL ELECTRIC HEATING BTU/HR.	MAX. UNIT WATTS HEATING	ELECTRICAL VOLTS PHASE HERTZ	ACCESSORIES	REFERENCE SELECTION
AC-1	8,800	7,000	11,600	3,600	240 1 60	WALL SLEEVE SUB. BASE	CARRIER 528Q A 3093

**UNIT HEATER SCHEDULE**

MARK	TOTAL HEATING BTU/HR. OUTPUT	TOTAL AIR CFM	MOTOR H.P.	ELECTRICAL VOLTS PHASE HERTZ	ACCESSORIES	REFERENCE SELECTION
UH-1	104,000	1600	1/20	120 1 60	24V TRANS T'STAT	REZTOR SERIES 100 MODEL FE
UH-2	100,000	-	-	120 1 60	-	RADIANT TYPE HEATER *

\* FURNISHED BY OWNER INSTALLED BY CONTRACTOR.


**AIR DEVICE SCHEDULE**

MARK	SIZE	DEVICE STYLE	AIR PATTERN	REMARKS
A	12 x 12	CEILING DIFFUSER	4 - WAY	①
B	9 x 9	CEILING DIFFUSER	4 - WAY	①
C	12 x 12	CEILING DIFFUSER	3 - WAY	①
D	6 x 6	CEILING DIFFUSER	4 - WAY	①
E	10" Ø	CEILING DIFFUSER	4 - WAY	②
F	72 x 14	RETURN AIR REG.	-	③
G	24 x 14	RETURN AIR REG.	-	③
H	6 x 6	CEILING DIFFUSER	2 - WAY	①


- ① TITUS TDC
- ② THERMA FUSER
- ③ TITUS 13 RL

**HVAC SYMBOLS**



SYMBOL	DESCRIPTION
	DUCTWORK FIRST NO. IS VISIBLE DIMENSION
	SPLITTER DAMPER
	DUCT TURN WITH TURNING VANES
	SUPPLY AIR WALL REGISTER
	CEILING SUPPLY AIR REGISTER
	DUCT SECTION SUPPLY AIR
	DUCT SECTION RETURN AIR AND OR EXHAUST AIR
	AIR DEVICE DESIGNATION WITH CFM/QUANTITY. SEE SCHEDULE
AC-1	AIR CONDITIONING UNIT DESIGNATION
F-1	FURNACE DESIGNATION
EF-1	EXHAUST FAN DESIGNATION
	THERMOSTAT
RL	REFRIGERANT LIQUID
RS	REFRIGERANT SUCTION
CD	CONDENSATE DRAIN PIPING

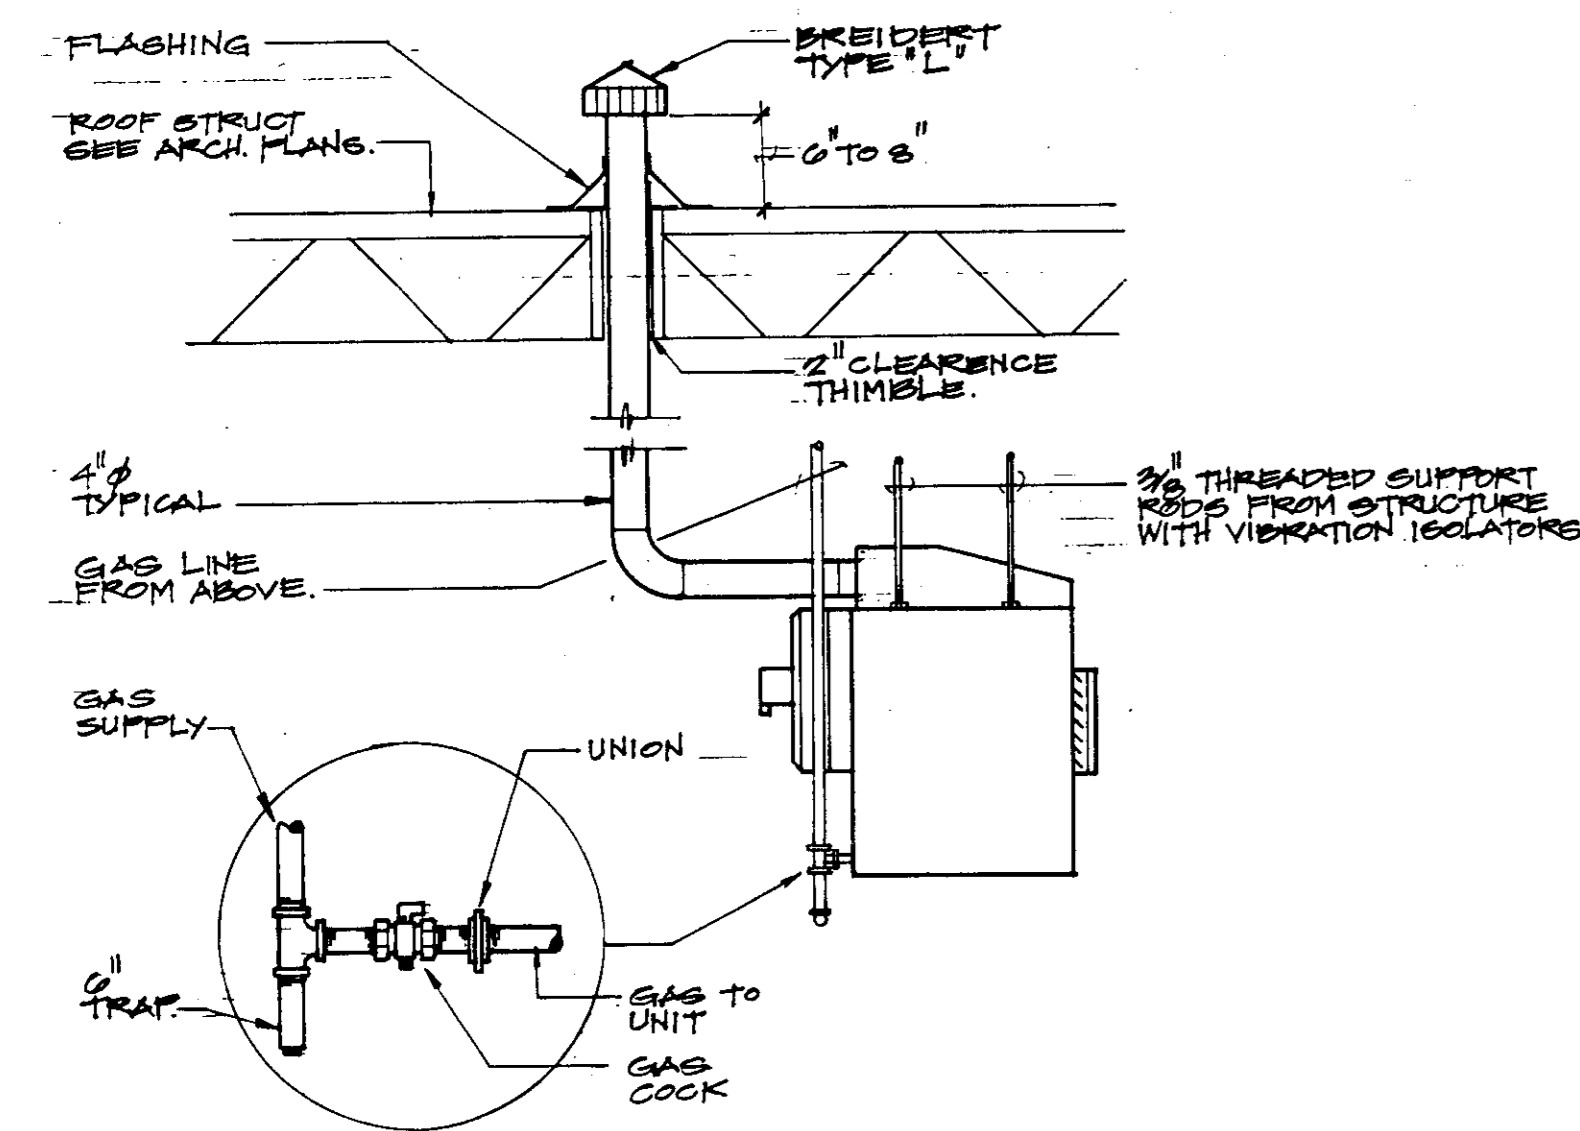

**102 UNIT HEATER DETAIL**  
NO SCALE

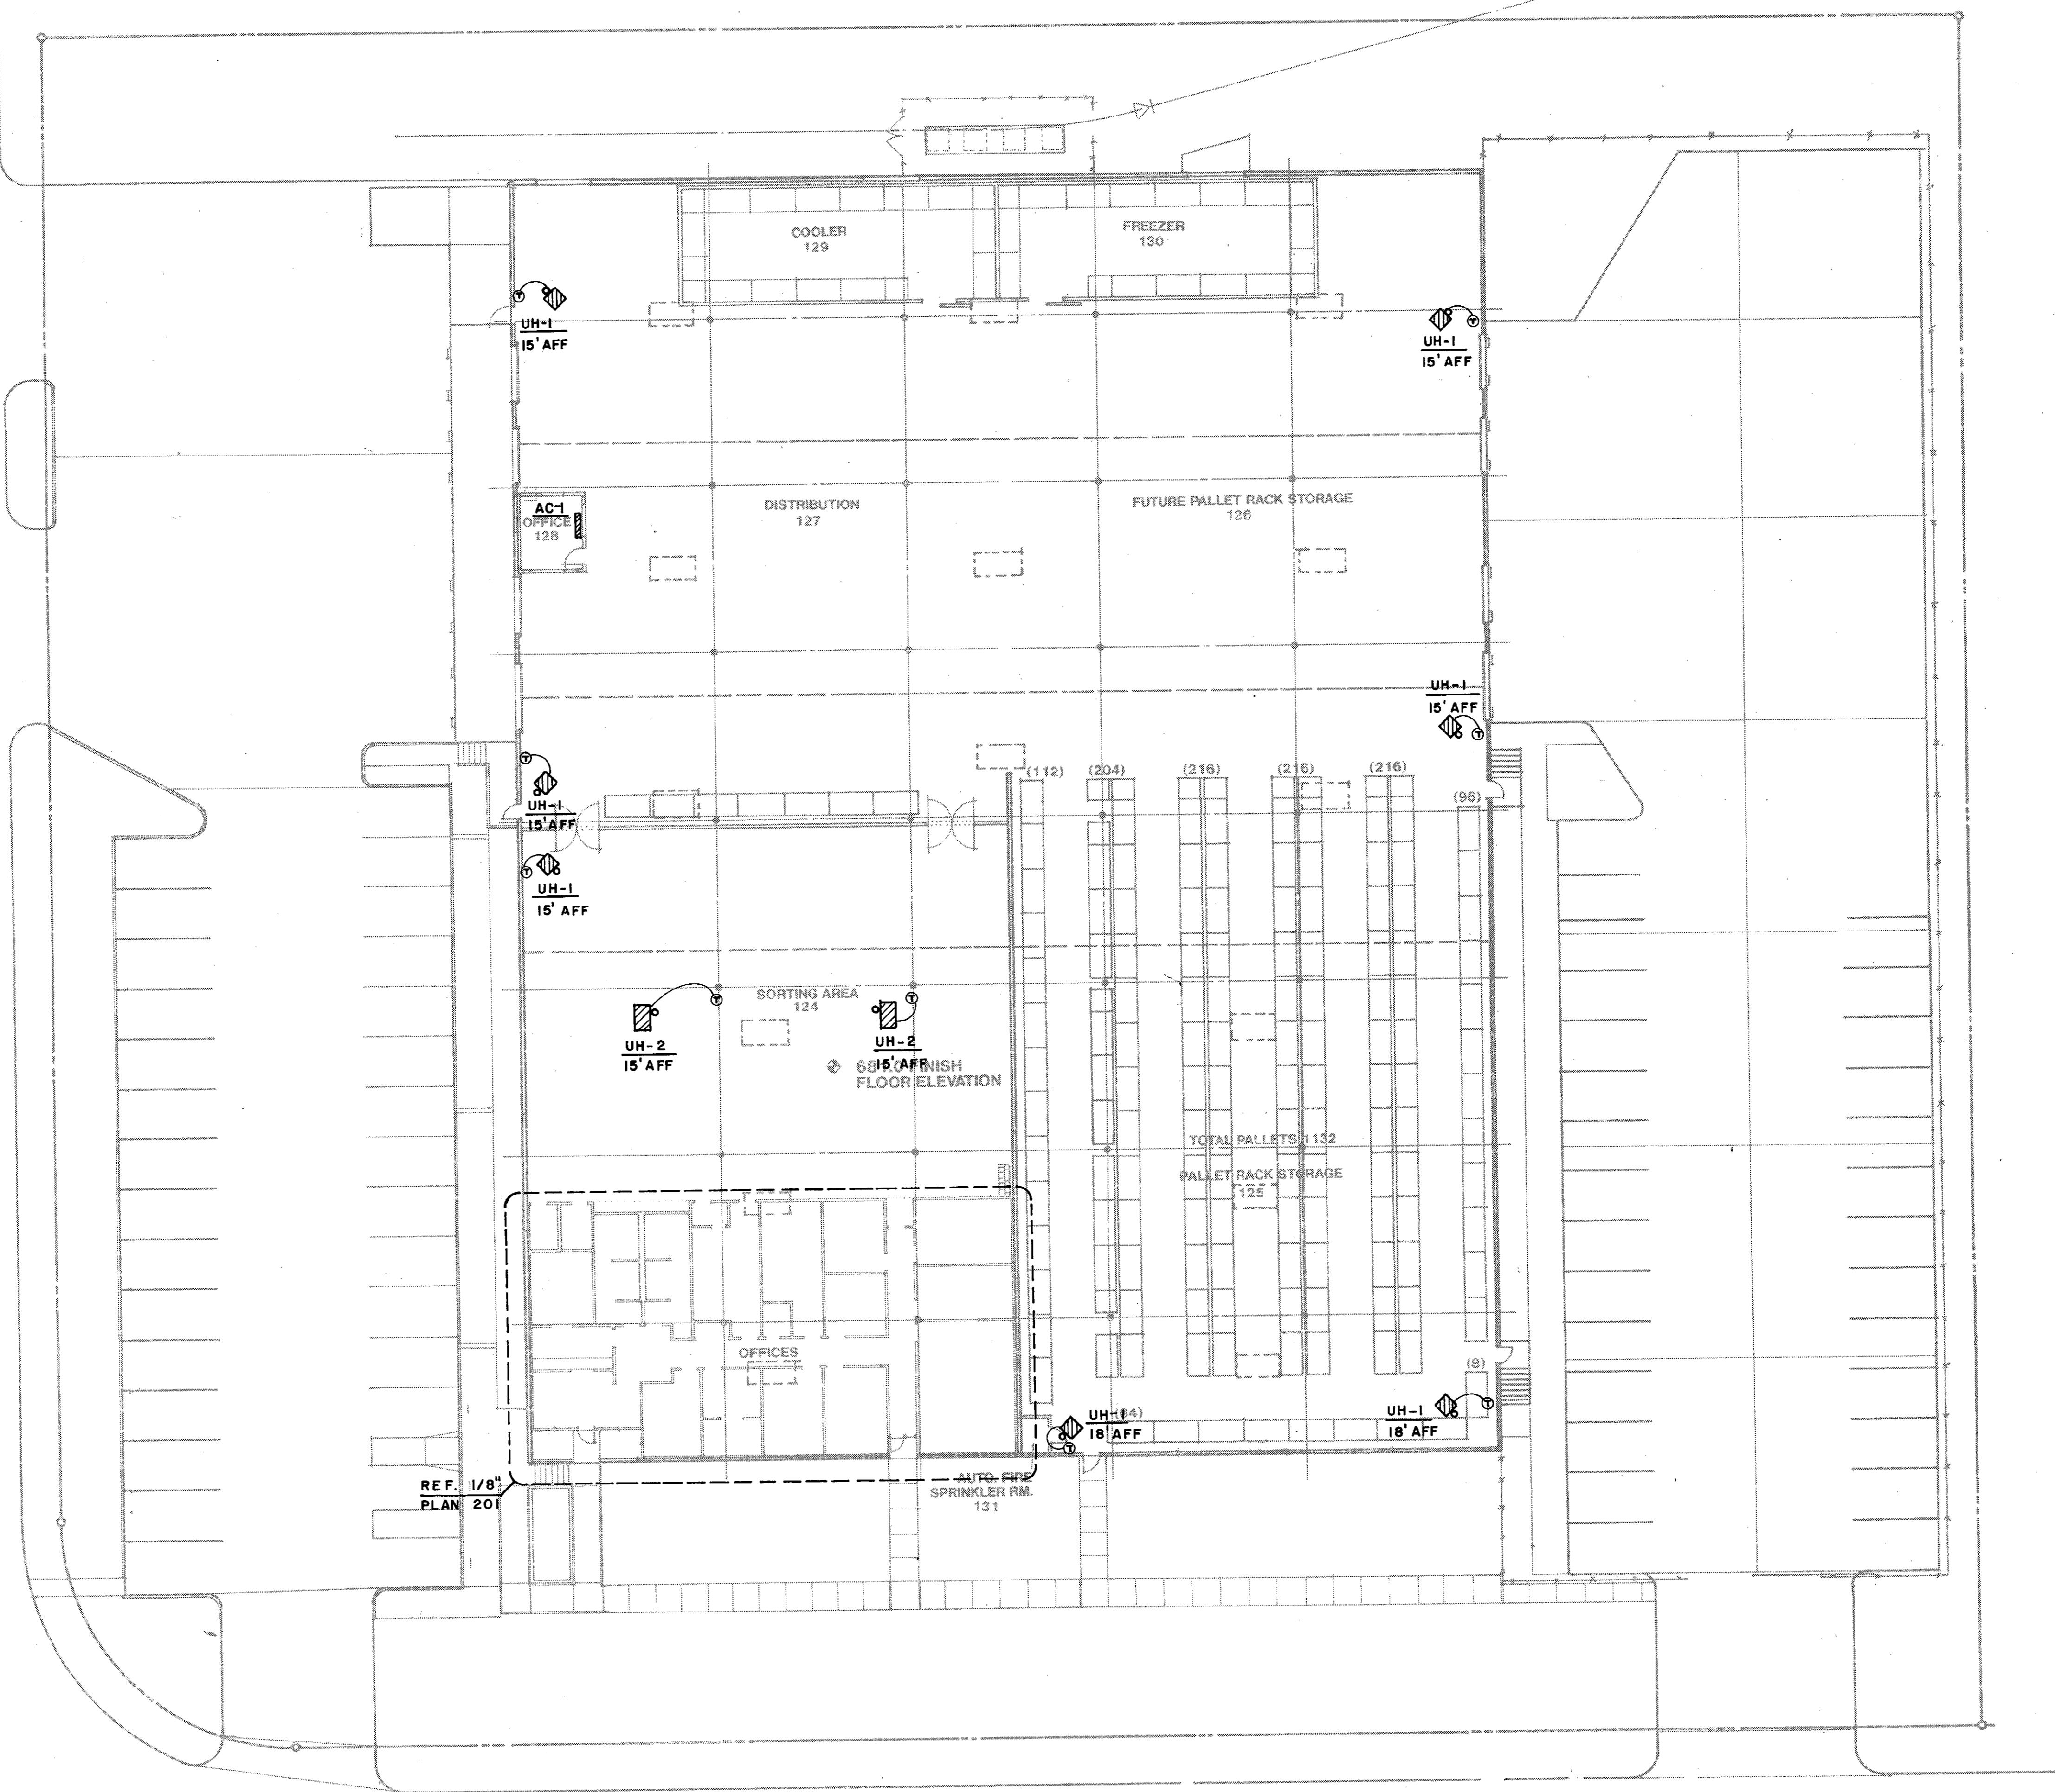

**101 HVAC FLOOR PLAN**  
SCALE: 1/16" = 1'-0"

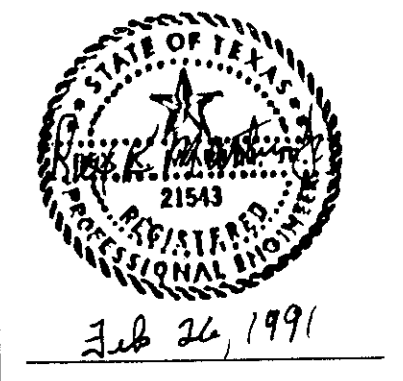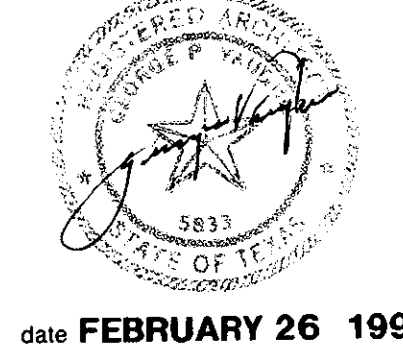

**ME inc**  
martin engineering inc.  
1901 ne military hwy.  
san antonio, tx 78215

**FOOD BANK**  
4311 DIRECTOR DRIVE  
SAN ANTONIO TEXAS

Rehler Vaughn  
Beaty & Koone, Inc.  
architecture  
interior architecture  
landscape architecture  
master planning

Trinity Plaza II Sixth Floor  
745 E. Mulberry  
San Antonio, Texas 78212  
512 733 3535  
**RVBK**  
architects